


PLAN
SCALE: 1"=20'

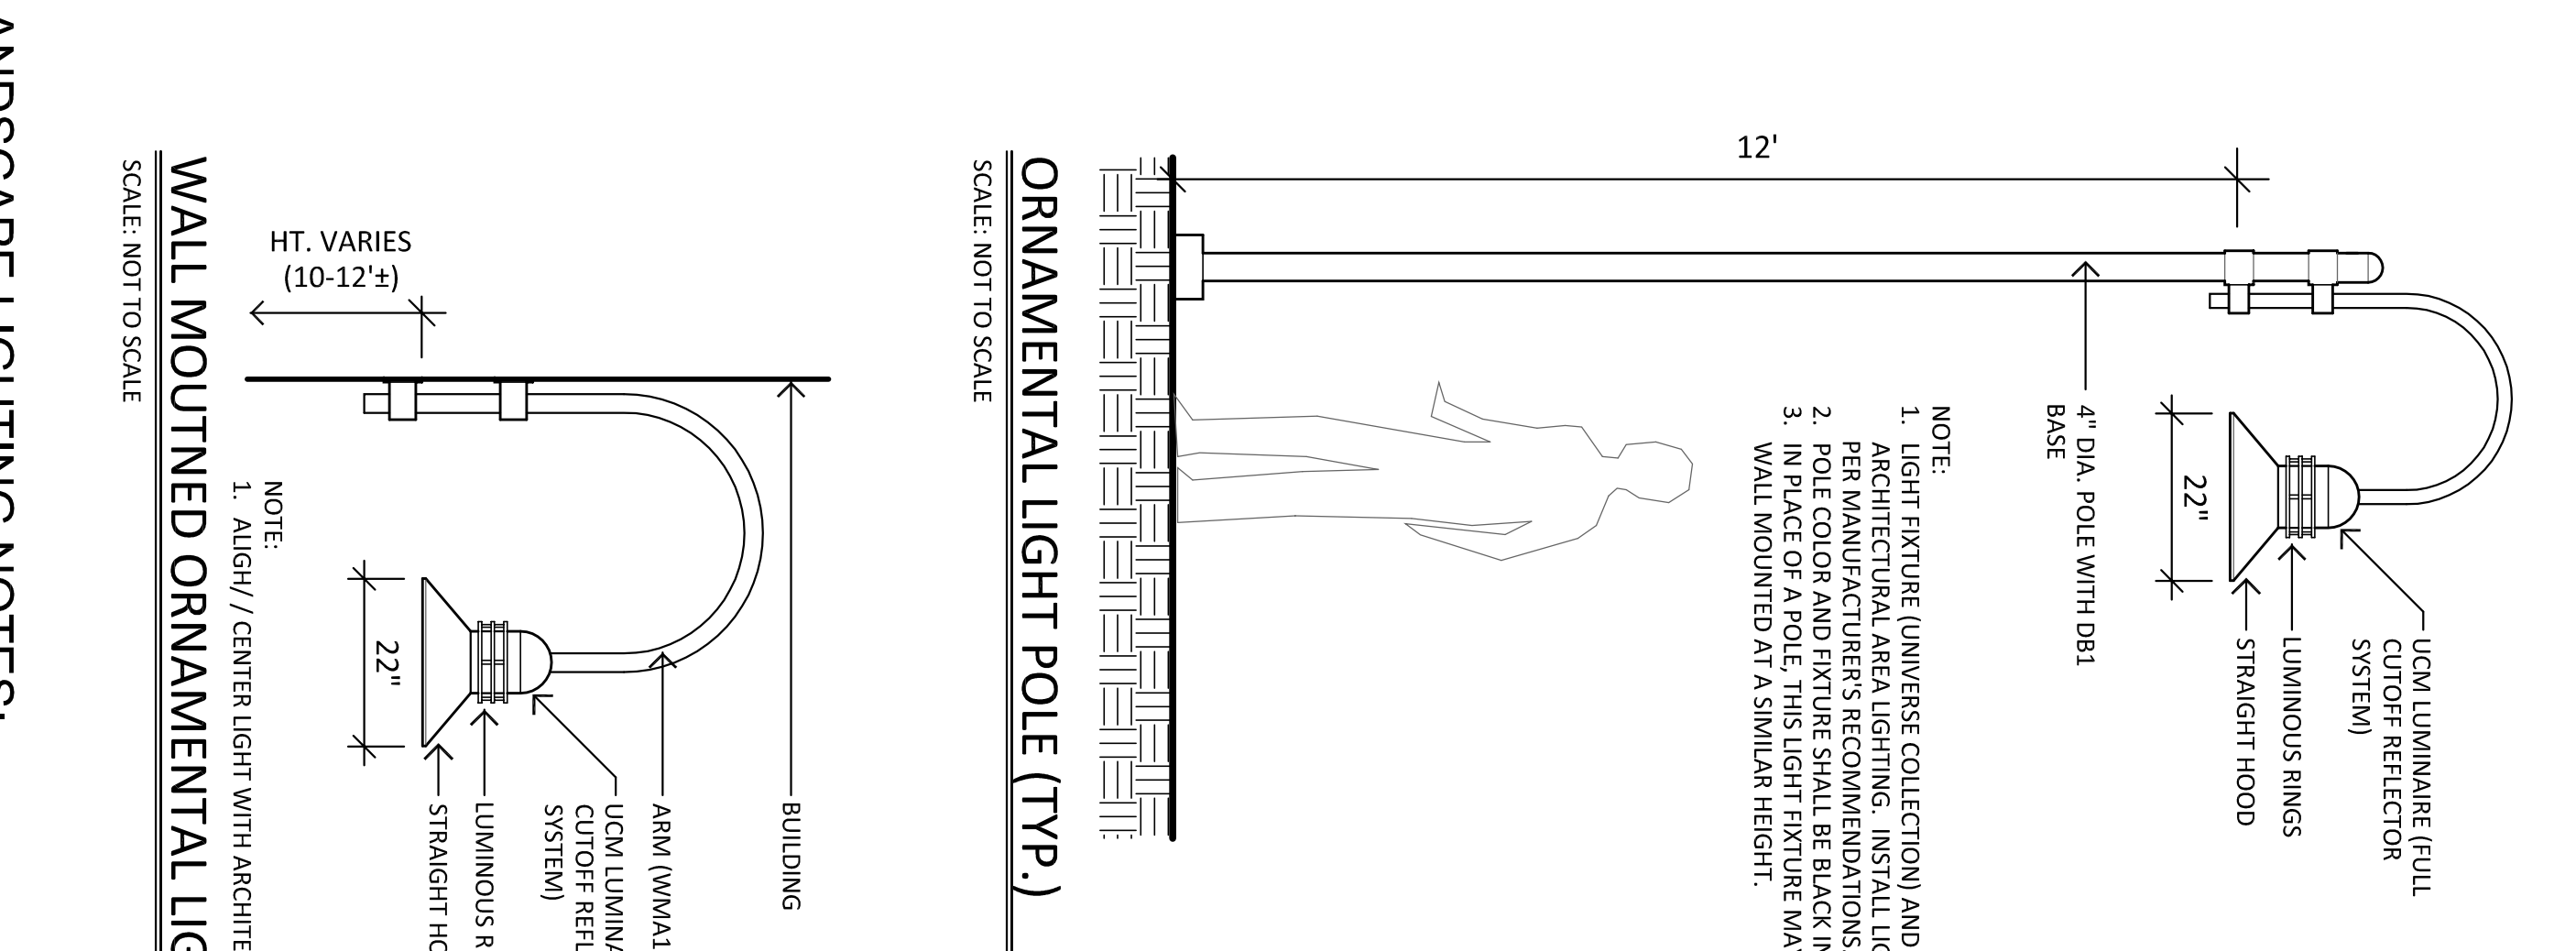


SCREENING FENCE (TYP.)
SCALE: NOT TO SCALE

NOTE:
1. FENCE SHALL BE WHITE VINYL.

GENERAL NOTES:

- EXISTING AND PROPOSED SITE INFORMATION TAKEN FROM A DIGITAL AUTOCAD SITE PLAN SUPPLIED BY REDNUS & MEAD, ENTITLED "SITE DEVELOPMENT PLAN", DATED 11/21/14.
- CONTRACTOR SHALL BE RESPONSIBLE FOR VERIFYING ALL UTILITIES PRIOR TO START OF ANY EXCAVATION WORK.
- EXACT LOCATION OF PROPOSED PLANTINGS AND SPECIES SHALL BE SHOWN FROM AN EXISTING SITE PLAN REVISIONS AND/OR ACTUAL FIELD CONDITIONS.
- PLANT SPECIES SUBSTITUTIONS MAY BE MADE WITH THE APPROVAL OF THE PROJECT LANDSCAPE ARCHITECT PRIOR TO PLANTING. SUBSTITUTED PLANTS SHALL BE AT AN EQUAL OR GREATER SIZE AS NOTED USING A SIMILAR TYPE PLANT.
- ALL PLANTING METHODS SHALL BE IN ACCORDANCE WITH THE "LANDSCAPE DESIGN HANDBOOK", LATEST EDITION, AS PUBLISHED BY THE AMERICAN NURSERY & LANDSCAPE ASSOCIATION.
- THE CONTRACTOR SHALL VERIFY WITH THE PROJECT ENGINEER THAT THE NEW PLANTINGS DO NOT INTERFERE WITH EXISTING AND/OR PROPOSED UTILITIES, SIGHT LINES, AND/OR STRUCTURES.
- THIS PLAN FOR PLANTING PURPOSES ONLY. SEE PLANS BY OTHERS FOR ADDITIONAL INFORMATION.

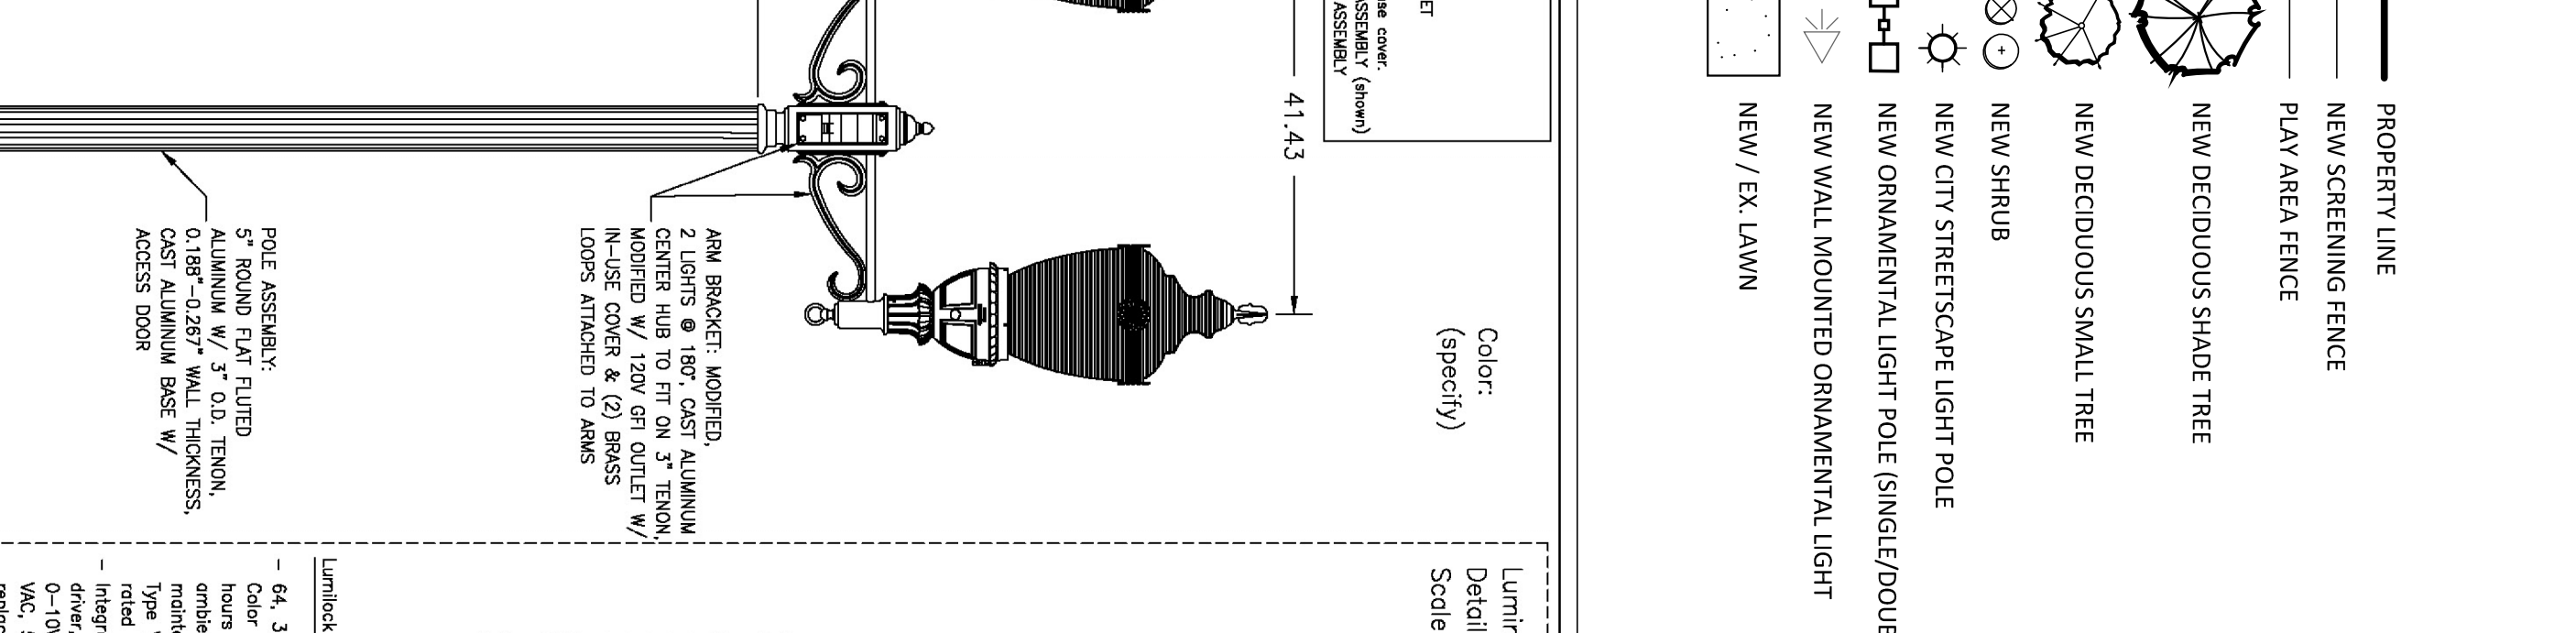

ORNAMENTAL LIGHT POLE (TYP.)
SCALE: NOT TO SCALE


NOTE:
1. LIGHT FIXTURE (UNIVERSE COLLECTION) AND POLE BY ARCHITECTURAL AREA LIGHTING. INSTALL LIGHT POLE PER MANUFACTURER'S RECOMMENDATIONS.
2. POLE COLOR AND FIXTURE SHALL BE BLACK IN COLOR.
3. IN PLACE OF A POLE, THIS LIGHT FIXTURE MAY BE WALL MOUNTED AT A SIMILAR HEIGHT.

LANDSCAPE LIGHTING NOTES:

- SITE LIGHTING INFORMATION AND LIGHTING PLANS PREPARED BY ENVIRONMENTAL LAND SOLUTIONS, LLC ARE DESIGNED FOR GENERAL LANDSCAPE AESTHETIC PURPOSES ONLY. LIGHTING INFORMATION SHOWN ON THIS PLAN SHALL NOT BE USED FOR SECURITY OR SAFETY PURPOSES.
- LOCATION AND TYPE OF LIGHT FIXTURES ARE TYPICAL AND MAY VARY BASED ON ACTUAL FIELD CONDITIONS, SITE AND ACCESSIBILITY. CONSULT WITH THE ARCHITECT FOR ANY CHANGES TO LIGHTING AND/OR MANUFACTURER.
- THIS PLAN ASSUMES THAT THE BUILDING WILL HAVE WALL MOUNTED FIXTURES (BY OTHERS) TO LIGHT THE FACADE AND ADJACENT LANDSCAPE AREAS (INCLUDING WALKS AND DOORS).
- INSTALL LIGHT FIXTURES AS RECOMMENDED BY THE MANUFACTURER.

PLANT LIST

QTY	KEY	BOTANICAL NAME	COMMON NAME	SIZE	ROOT	NOTE
AR	AR	ACER RUBRUM 'ARMSTRONG'	ARMSTRONG RED MAPLE	2 1/2-3" CAL.	B&B	14-15 HT. @ PLANTING, 50' MATURE HT.
GP	GP	QUERCUS PALUSTRIS 'SPACIFIC BRILLIANCE'	PIN OAK	2 1/2-3" CAL.	B&B	14-15 HT. @ PLANTING, 60' MATURE HT.
SP	SP	AMELANCHIER LAEVIS 'SPRING BRILLIANCE'	SPRING FLUWY SHAD	2-2 1/2" CAL.	B&B	12-13' HT. @ PLANTING, 20' MATURE HT.
GG	GG	THUJA GREEN GIANT	GREEN GIANT ARBORVITAE	5-6" HT.	B&B	5-6' HT. @ PLANTING, 25' MATURE HT.
TO	TO	THUJA OCCIDENTALIS 'NIGRA'	THE ORIGINAL HYDRANGEA	6-7" HT.	B&B	6-7' HT. @ PLANTING, 25' MATURE HT.
HY	HY	ILEX CRENATA 'CHESAPEAKE'	CHESAPEAKE HOLLY	3-4" HT.	B&B	
IC	IC	ILEX CRENATA 'HOOGENDOORN'	HOOGENDOORN HOLLY	2-3" HT.	CONT.	
HE	HE	ILEX GLABRA 'SHARROCK'	SARGENT JUNIPER	2-3" HT.	CONT.	
HO	HO	ILEX PERPERUS 'CHIHENSIS VAR. SARGENTI'	CHIHENSIS JUNIPER	2-3" HT.	CONT.	
IG	IG	JUNIPERUS COMMENSALIS 'BLUE PACIFIC'	BLUE PACIFIC JUNIPER	2-3" HT.	CONT.	
JR	JR	ROSA 'WHITE MELODIAN'	WHITE MELODIAN ROSE	2-3" HT.	CONT.	
WR	WR	TAXUS BACCATA 'REPANDENS'	REPANDENS ENGLISH YEW	2-3" HT.	CONT.	
TX	TX	THUJA OCCIDENTALIS 'HOLMSTRUP'	HOLMSTRUP ARBORVITAE	30-36" HT.	B&B	
HR	HR	HEMLOCKALUS 'HAPPY RETURNS'	HAPPY RETURNS DAVILIA	1 QT.	B&B	
PH	PH	PERNETIUM ALOPECUROIDES 'HAMMEL'	HAMMEL PACHISANDRA	1 QT.	B&B	
PT	PT	PACHISANDRA TERMINALIS	PACHISANDRA	BR	B&B	

 

WALL MOUNTED ORNAMENTAL LIGHT (TYP.)
SCALE: NOT TO SCALE

NOTE:
1. ALIGN / CENTER LIGHT WITH ARCHITECTURE FEATURES.

LEGEND

- PROPERTY LINE
- NEW SCREENING FENCE
- PLAY AREA FENCE
- NEW DECIDUOUS SHADE TREE
- NEW DECIDUOUS SMALL TREE
- NEW SHRUB
- NEW CITY STREETSCAPE LIGHT POLE
- NEW ORNAMENTAL LIGHT POLE (SINGLE/DOUBLE FIXTURE)
- NEW WALL MOUNTED ORNAMENTAL LIGHT
- NEW / EX. LAWN

CITY STREETSCAPE LIGHT POLE

NOTES:
1. POLE AND FIXTURE COLOR SHALL BE GREEN.
2. FIXTURE SHALL HAVE FULL TOP REFLECTOR.
3. POLE SHALL BE 10' IN HEIGHT WITH GFI OUTLET.

LANDSCAPE PLAN

PROJECT: 819 EAST MAIN STREET STAMFORD, CONNECTICUT

SCALE: AS SHOWN

DATE: 4.23.21

DRAWING NO.: LP.1

ENVIRONMENTAL LAND SOLUTIONS, LLC
Landscape Architecture and Environmental Planning
8 KNIGHT STREET SUITE 203
NORWALK, CONNECTICUT 06851
Tel: (203) 855-7879 Fax: (203) 855-7836
info@elslc.net www.elslc.net

PHILIPS HARBICO
100 Oakley Drive
Lisle, IL 60115
Tel: 717-259-9289
www.philips.com

PHILIPS LED Specifications:
- 61, 300K (warm) LED, typical 75,000 hours of operational life (L70 B50)
- Color rendering index (CRI) > 90
- Ambient temperature & 70K Lumen maintenance, injection molded
- Integral Philips Advance Xitanium LED driver, class 1, IP68 rated, 350mA, 0.18W-0.28W, wall thickness, 0.18mm, 1.5mm, 1.8mm, 2.0mm, 2.2mm, 2.5mm, 3.0mm, 3.5mm, 561.0mm, 5